



THE DRAWER ASSURES THAT THE ANNUAL LIABILITY OF PERSONAL LIABILITY FOR THE DESIGN AND CONSTRUCTION OF THIS PROJECT IS THE ACTUAL AMOUNT OF FEE.

Chris DiCerbo

Building Renovation

Code Review
Floor Plan &
Fire Alarm Plan

Project Number: 01
Date: 03/08/2016
Drawn By: RCW

A1


Scale: As indicated

CODE SUMMARY


<ul style="list-style-type: none"> 1. Fire alarm received, 1000 SF 2. Occupant load, 100 or greater 3. Fire area of 400 sq ft or greater Level of construction is other than Type V <p>Action: Single any building</p>	<ul style="list-style-type: none"> 1. Fire area received, 1000 SF 2. Occupant load, 100 or greater 3. Fire area of 400 sq ft or greater Level of construction is other than Type V <p>Action: Single any building</p>
<p>Alternative Automatic Fire Detection System, 904 Commercial Cooking Systems, 904.11 Portable fire extinguishers, 905 Section 907.1.1, Refer to Fire Code of NYC Fire Alarm Detection System, 907 Section 907.2.1, General Requirements Fire Alarm Control Panel, 907.4 Section 907.4.1, General Requirements Section 907.4.1.1 Section 907.4.2, General Requirements Section 907.4.2.1, General Requirements</p>	<p>Alternative Automatic Fire Detection System, 904 Commercial Cooking Systems, 904.11 Portable fire extinguishers, 905 Section 907.1.1, Refer to Fire Code of NYC Fire Alarm Detection System, 907 Section 907.2.1, General Requirements Fire Alarm Control Panel, 907.4 Section 907.4.1, General Requirements Section 907.4.1.1 Section 907.4.2, General Requirements Section 907.4.2.1, General Requirements</p>
<p>Systems to meet requirements of Division 75. Alarm Remote Station</p>	<p>Systems to meet requirements of Division 75. Alarm Remote Station</p>
<p>Systems to meet requirements of Division 75. Alarm Remote Station</p>	<p>Systems to meet requirements of Division 75. Alarm Remote Station</p>
<p>Systems to meet requirements of Division 75. Alarm Remote Station</p>	<p>Systems to meet requirements of Division 75. Alarm Remote Station</p>
<p>Systems to meet requirements of Division 75. Alarm Remote Station</p>	<p>Systems to meet requirements of Division 75. Alarm Remote Station</p>
<p>Systems to meet requirements of Division 75. Alarm Remote Station</p>	<p>Systems to meet requirements of Division 75. Alarm Remote Station</p>
<p>Systems to meet requirements of Division 75. Alarm Remote Station</p>	<p>Systems to meet requirements of Division 75. Alarm Remote Station</p>

FIRE ALARM SYMBOL LEGEND

(S)	SMOKE DETECTOR
(H)	HEAT DETECTOR
(P)	PULL STATION
(C)	FIRE ALARM CONTROL PANEL
(A)	HORN/SIRONE
(S)	STROKE ONLY
(A/S)	KITCHEN ANALYST SYSTEM
(F)	FREEDMANS

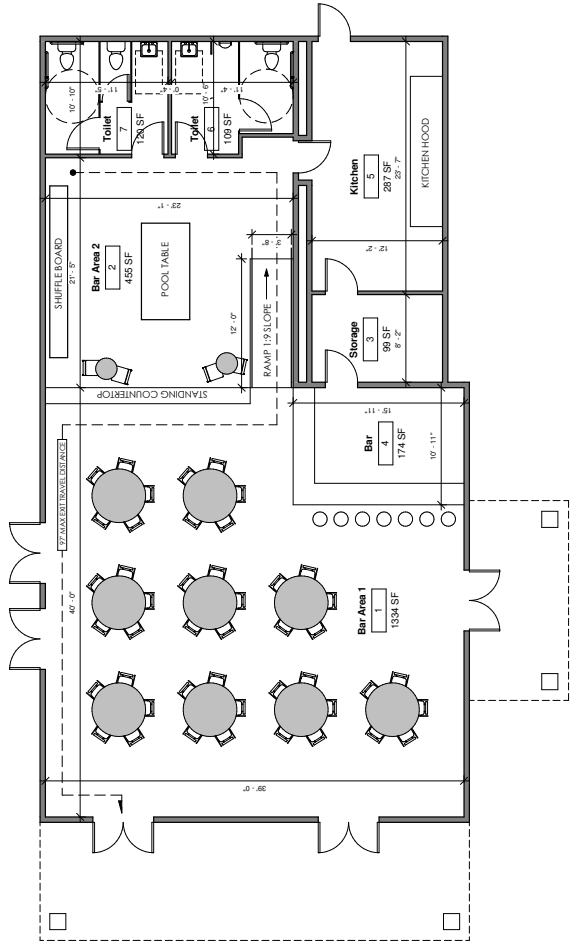

① Floor Plan
3/16" = 1'-0"

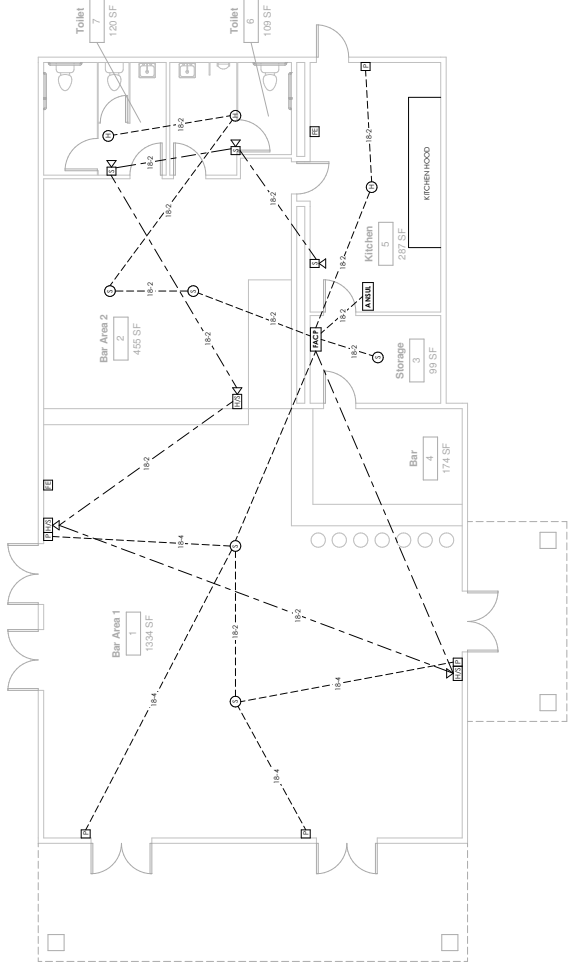

② Fire Alarm Plan
3/16" = 1'-0"